 



Legend

— Roads

Service Area

- Brays Bayou Service Area
- Buffalo/White Oak Service Area
- Clear Creek Service Area
- Greens Bayou Service Area
- Hunting Bayou Service Area
- San Jacinto Service Area
- Sims/Vince Service Area
- Clear Lake Water Authority (Excluded from Clear Creek Service Area)

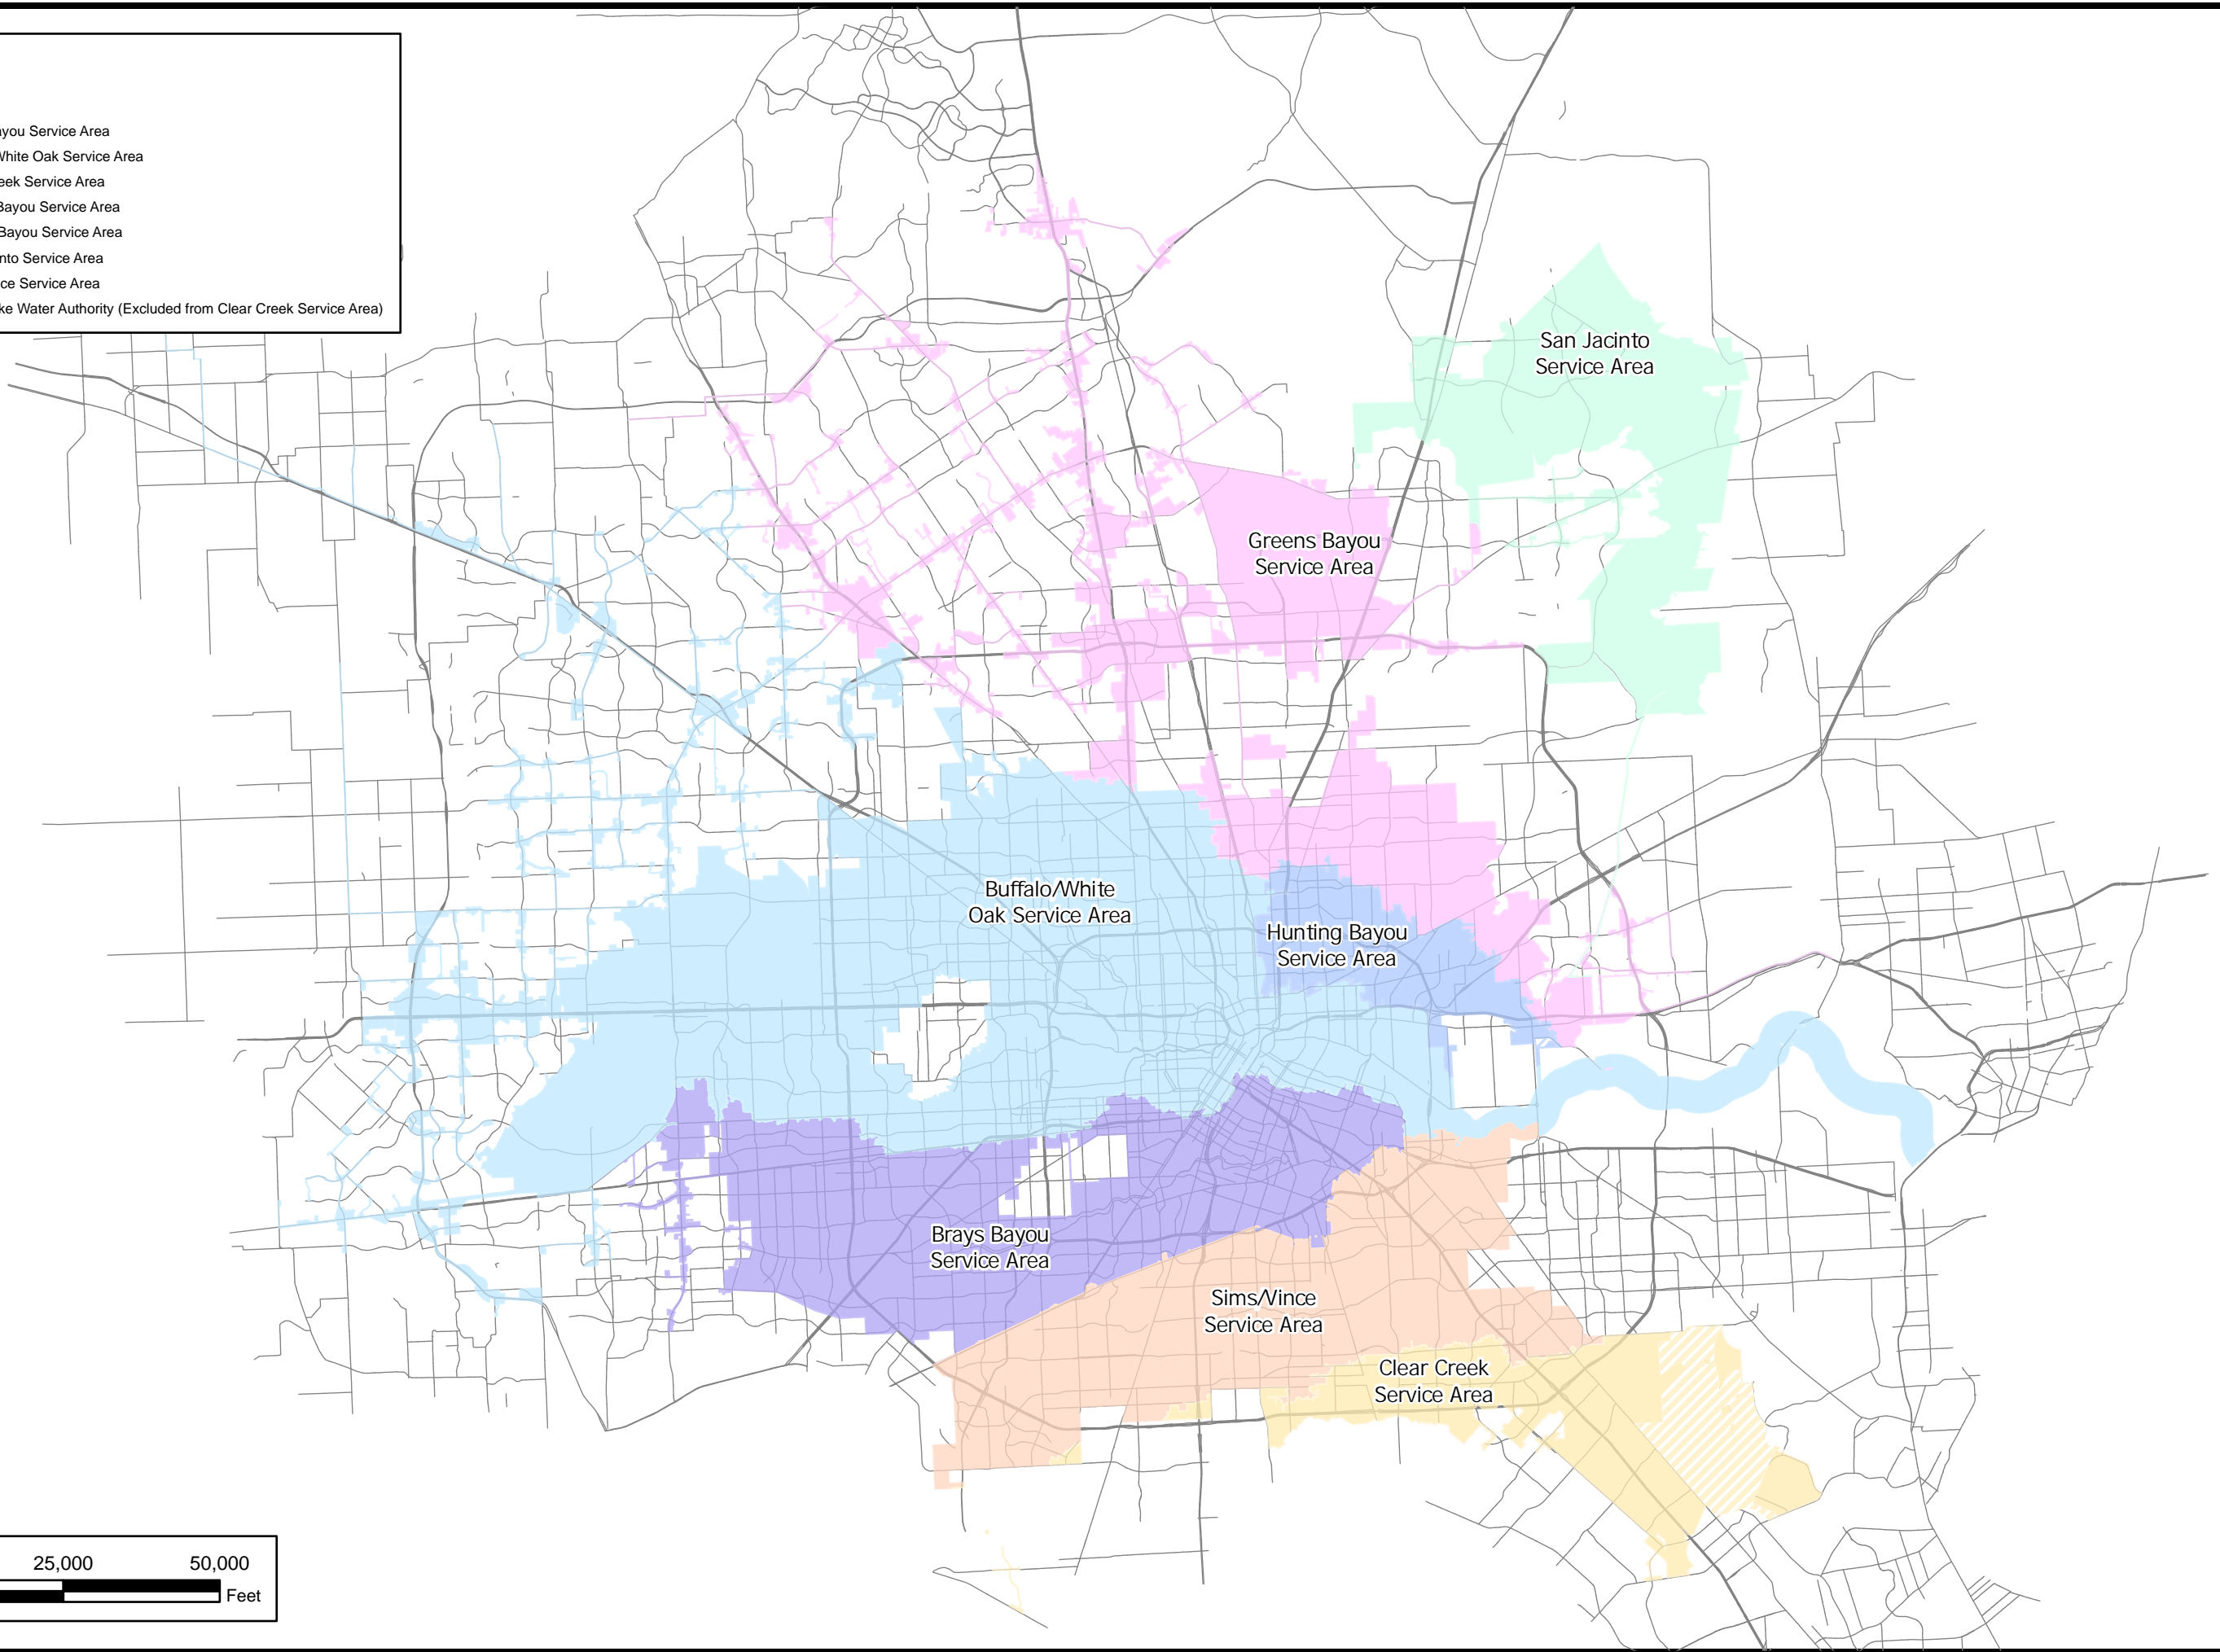


DATE:	2023
DESIGN:	KEP
DRAWN:	JWC
CHECKED:	SDG
KHA NO:	061285302








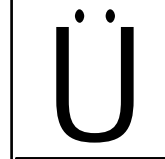





**SHEET
A1**




Service Area Exhibit

   **Houston Drainage Impact Fee
Houston, Texas**




Kimley»Horn
13455 Noel Road, Suite 700
Dallas, TX 75240
(972) 770-9300 Phone
(972) 239-3820 Fax
Engineering Firm Registration No. F-928

 - Legend**
-  Regional Projects
 -  2022 CIP Projects
 -  Comprehensive Drainage Plan Projects
 -  2022 DIFIP Projects
 -  Roads
- Service Area**
-  Brays Bayou Service Area
 -  Buffalo/White Oak Service Area
 -  Clear Creek Service Area
 -  Greens Bayou Service Area
 -  Hunting Bayou Service Area
 -  San Jacinto Service Area
 -  Sims/Vince Service Area
 -  Clear Lake Water Authority (Excluded from Clear Creek Service Area)

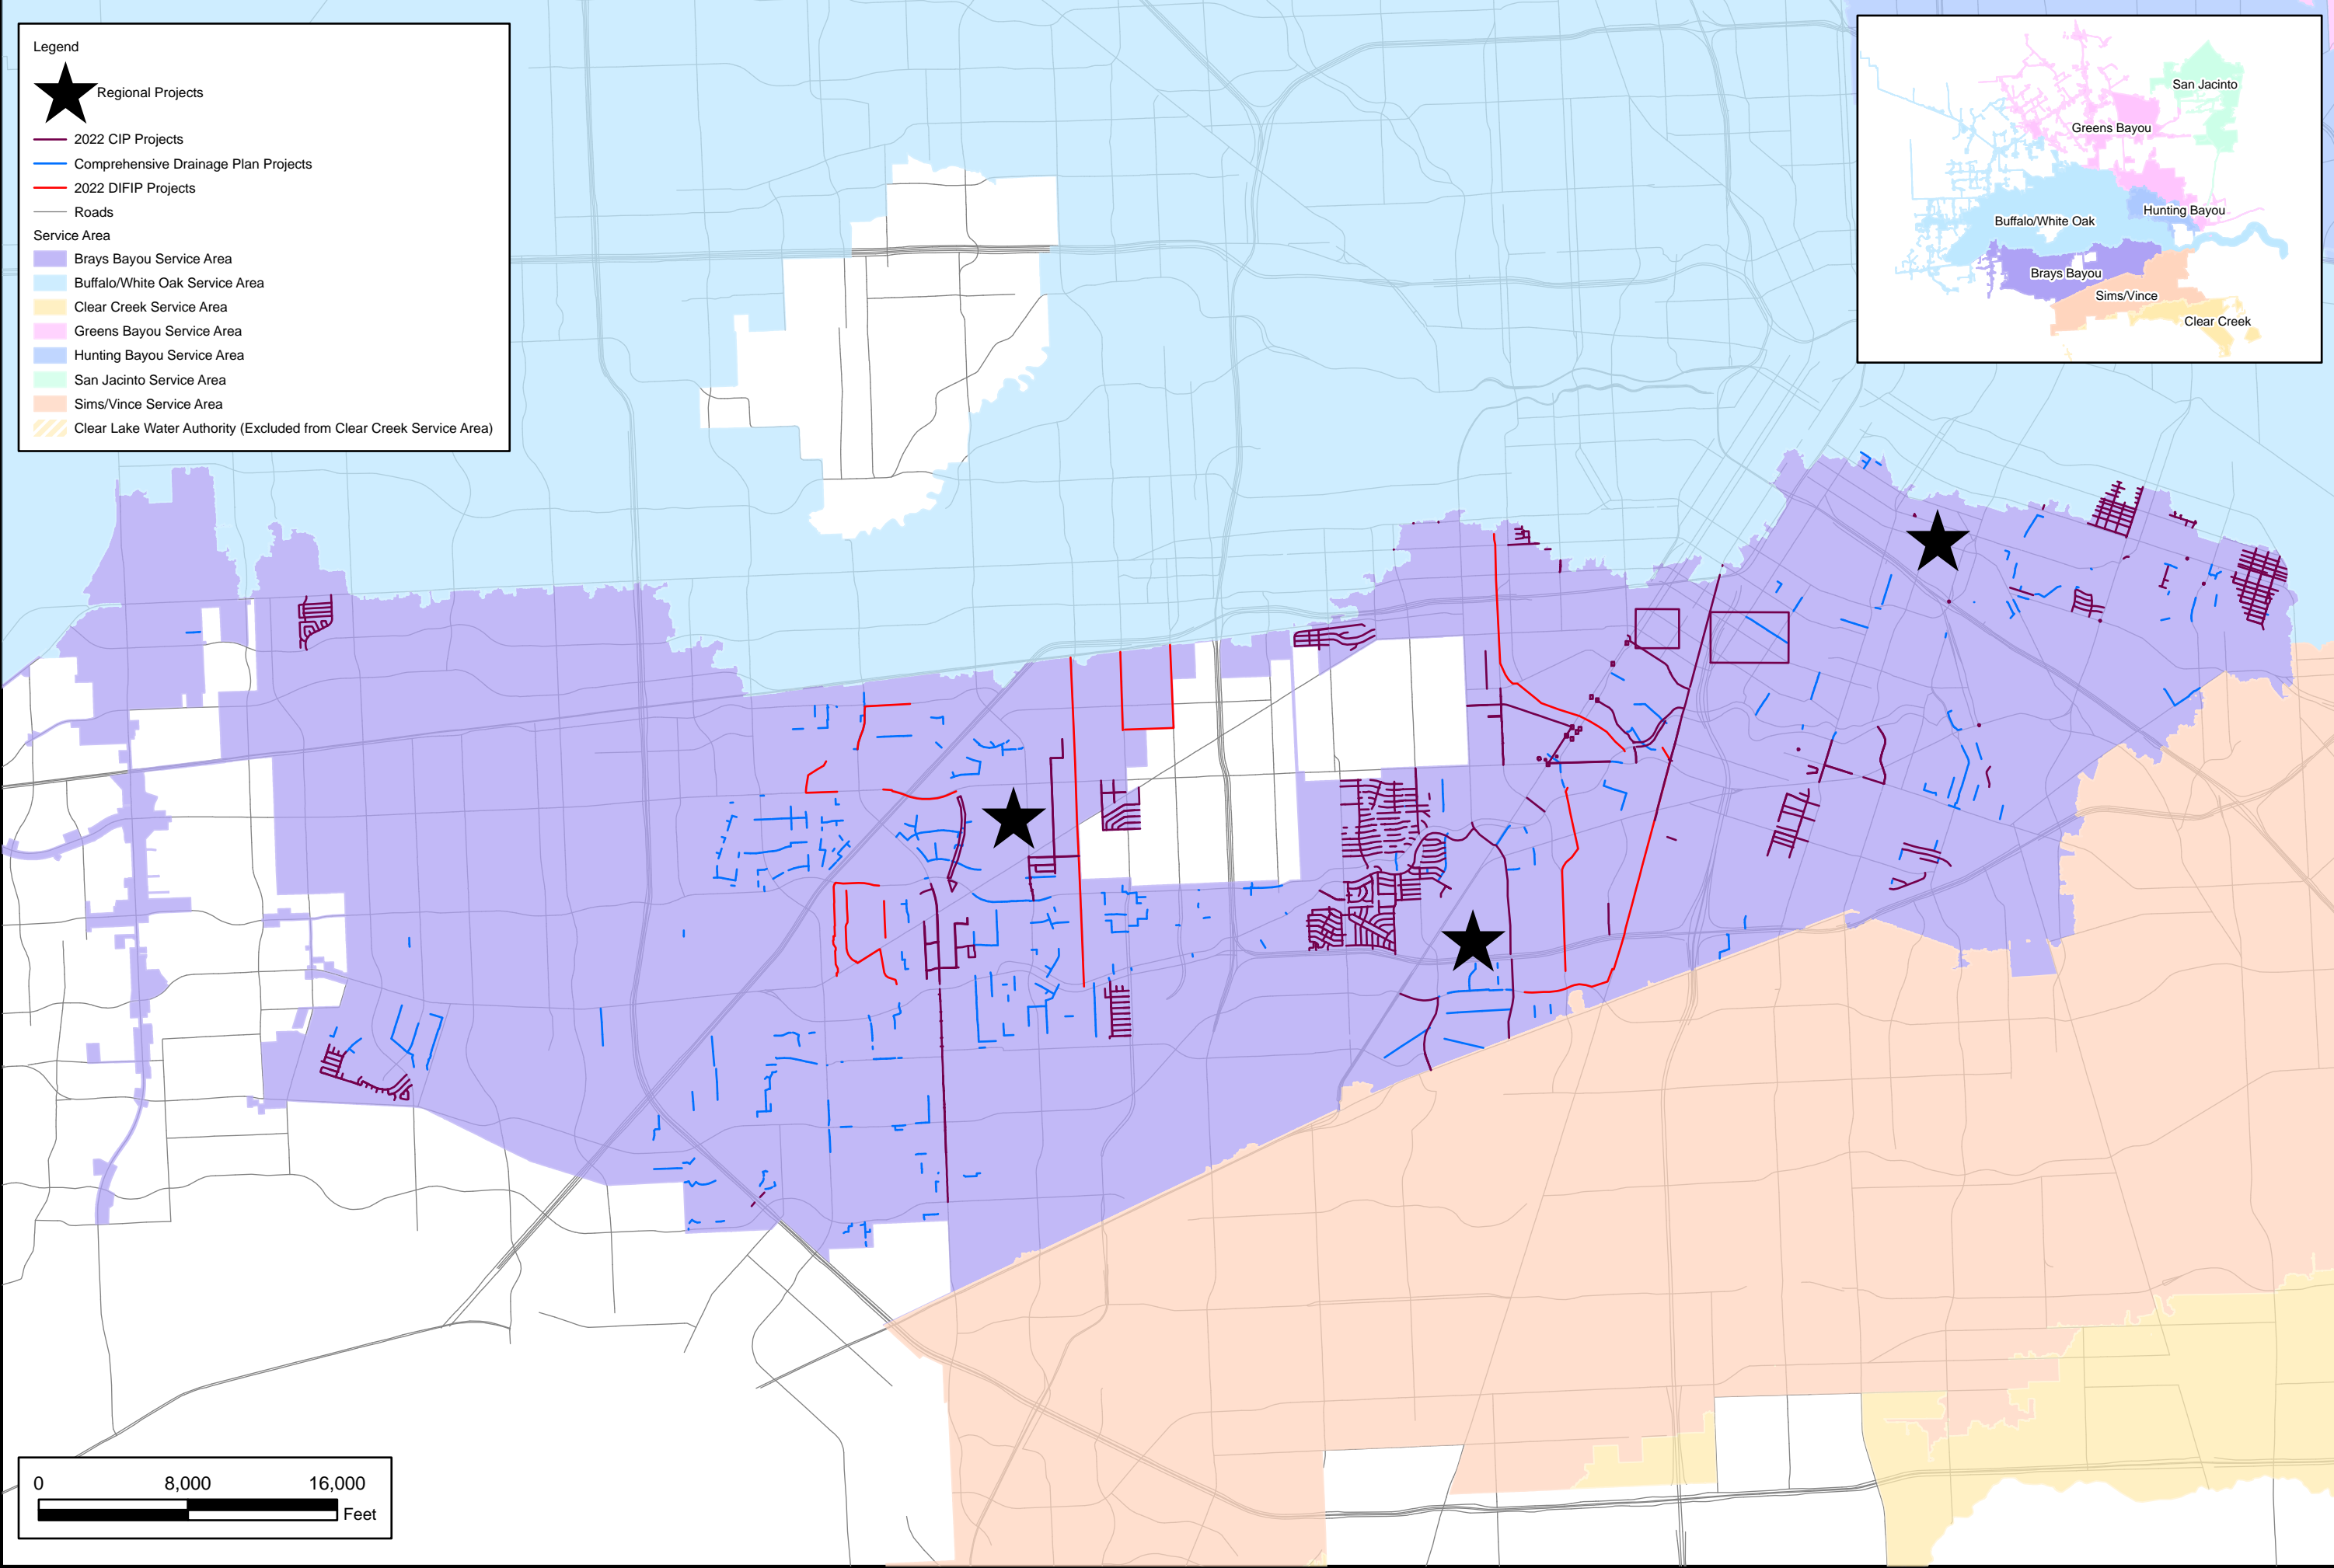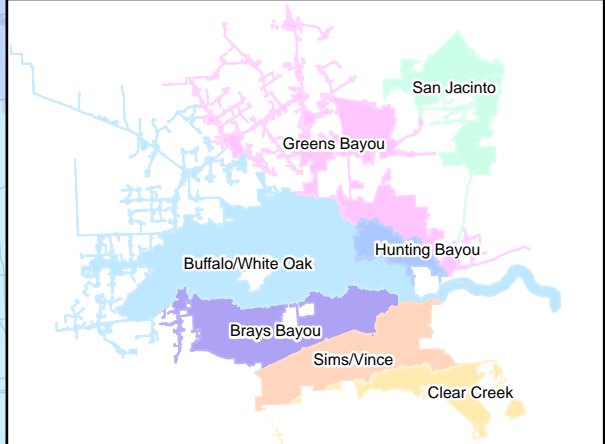

Kimley»Horn
 13455 Noel Road, Suite 700
 Dallas, TX 75240
 (972) 770-3000 Phone
 (972) 239-3820 Fax
 Engineering Firm Registration No. F-928

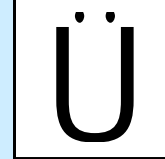

Houston Drainage Impact Fee
 Houston, Texas

Drainage Impact Fee
 Improvement Plan:
 Brays Bayou Service Area

DATE:	2023
DESIGN:	KEP
DRAWN:	JWC
CHECKED:	SDG
KHA NO.:	061285302

 


**SHEET
A2**

Legend

- ★ Regional Projects
- 2022 CIP Projects
- Comprehensive Drainage Plan Projects
- 2022 DIFIP Projects
- Roads

Service Area

- Brays Bayou Service Area
- Buffalo/White Oak Service Area
- Clear Creek Service Area
- Greens Bayou Service Area
- Hunting Bayou Service Area
- San Jacinto Service Area
- Sims/Vince Service Area
- Clear Lake Water Authority (Excluded from Clear Creek Service Area)

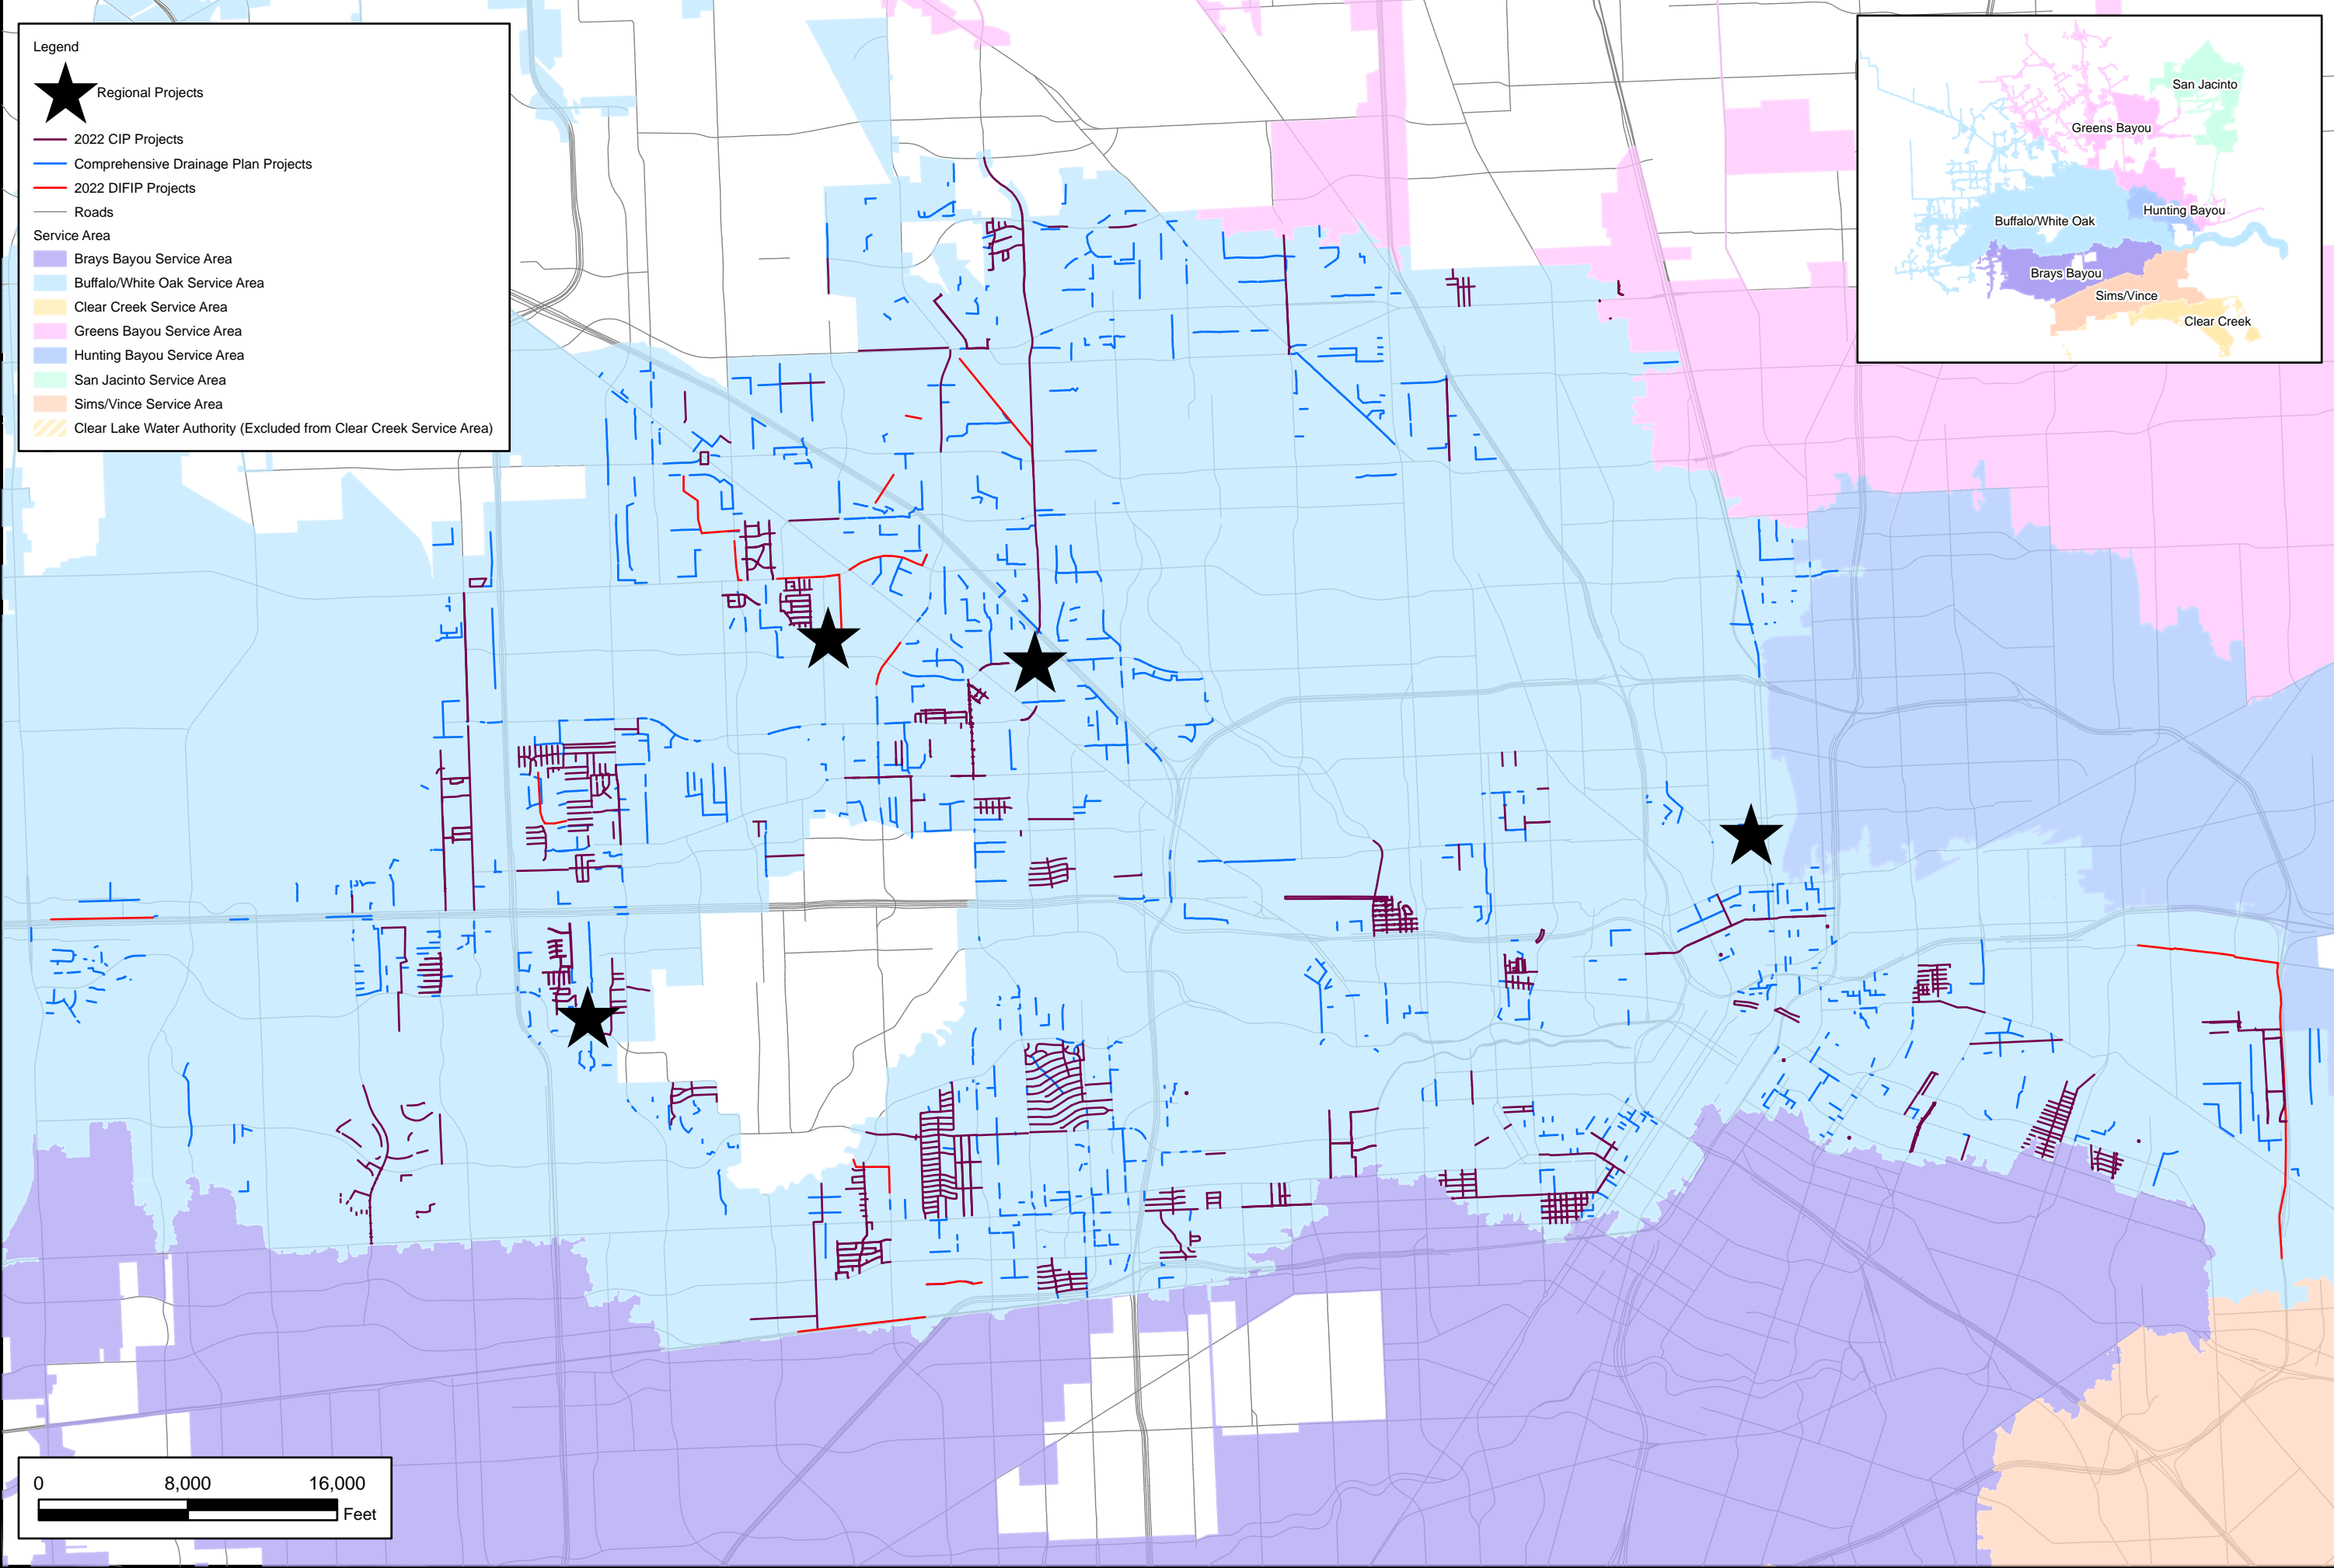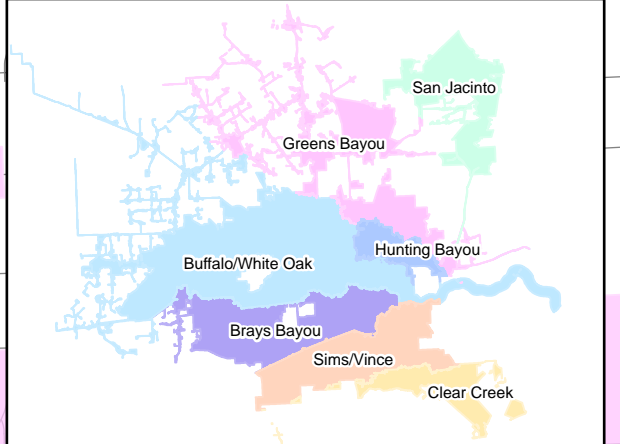

Kimley»Horn
 13455 Noel Road, Suite 700
 Dallas, TX 75240
 (972) 770-3000 Phone
 (972) 239-3820 Fax
 Engineering Firm Registration No. F-928





Houston Drainage Impact Fee
 Houston, Texas

Drainage Impact Fee
 Improvement Plan:
 Buffalo/White Oak Service Area

DATE:	2023
DESIGN:	KEP
DRAWN:	JWC
CHECKED:	SDG
KHA NO.:	061285302

 **SHEET
 A3**

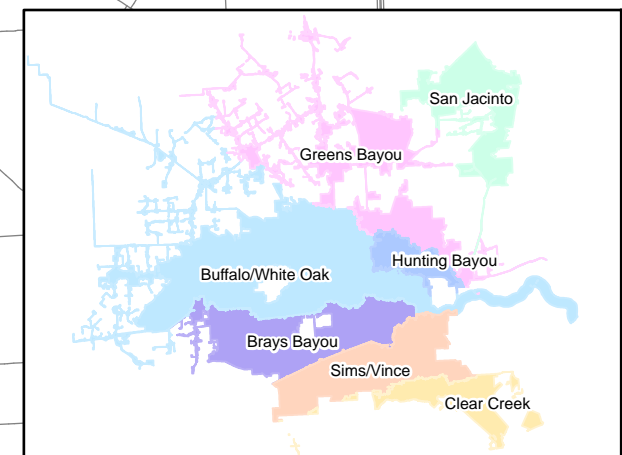

Kimley»Horn
 13455 Noel Road, Suite 700
 Dallas, TX 75240
 (972) 770-3000 Phone
 (972) 239-3820 Fax
 Engineering Firm Registration No. F-928




Houston Drainage Impact Fee
 Houston, Texas

Drainage Impact Fee
 Improvement Plan:
 Clear Creek Service Area

DATE:	2023
DESIGN:	KEP
DRAWN:	JWC
CHECKED:	SDG
KHA NO.:	061285302

**SHEET
A4**


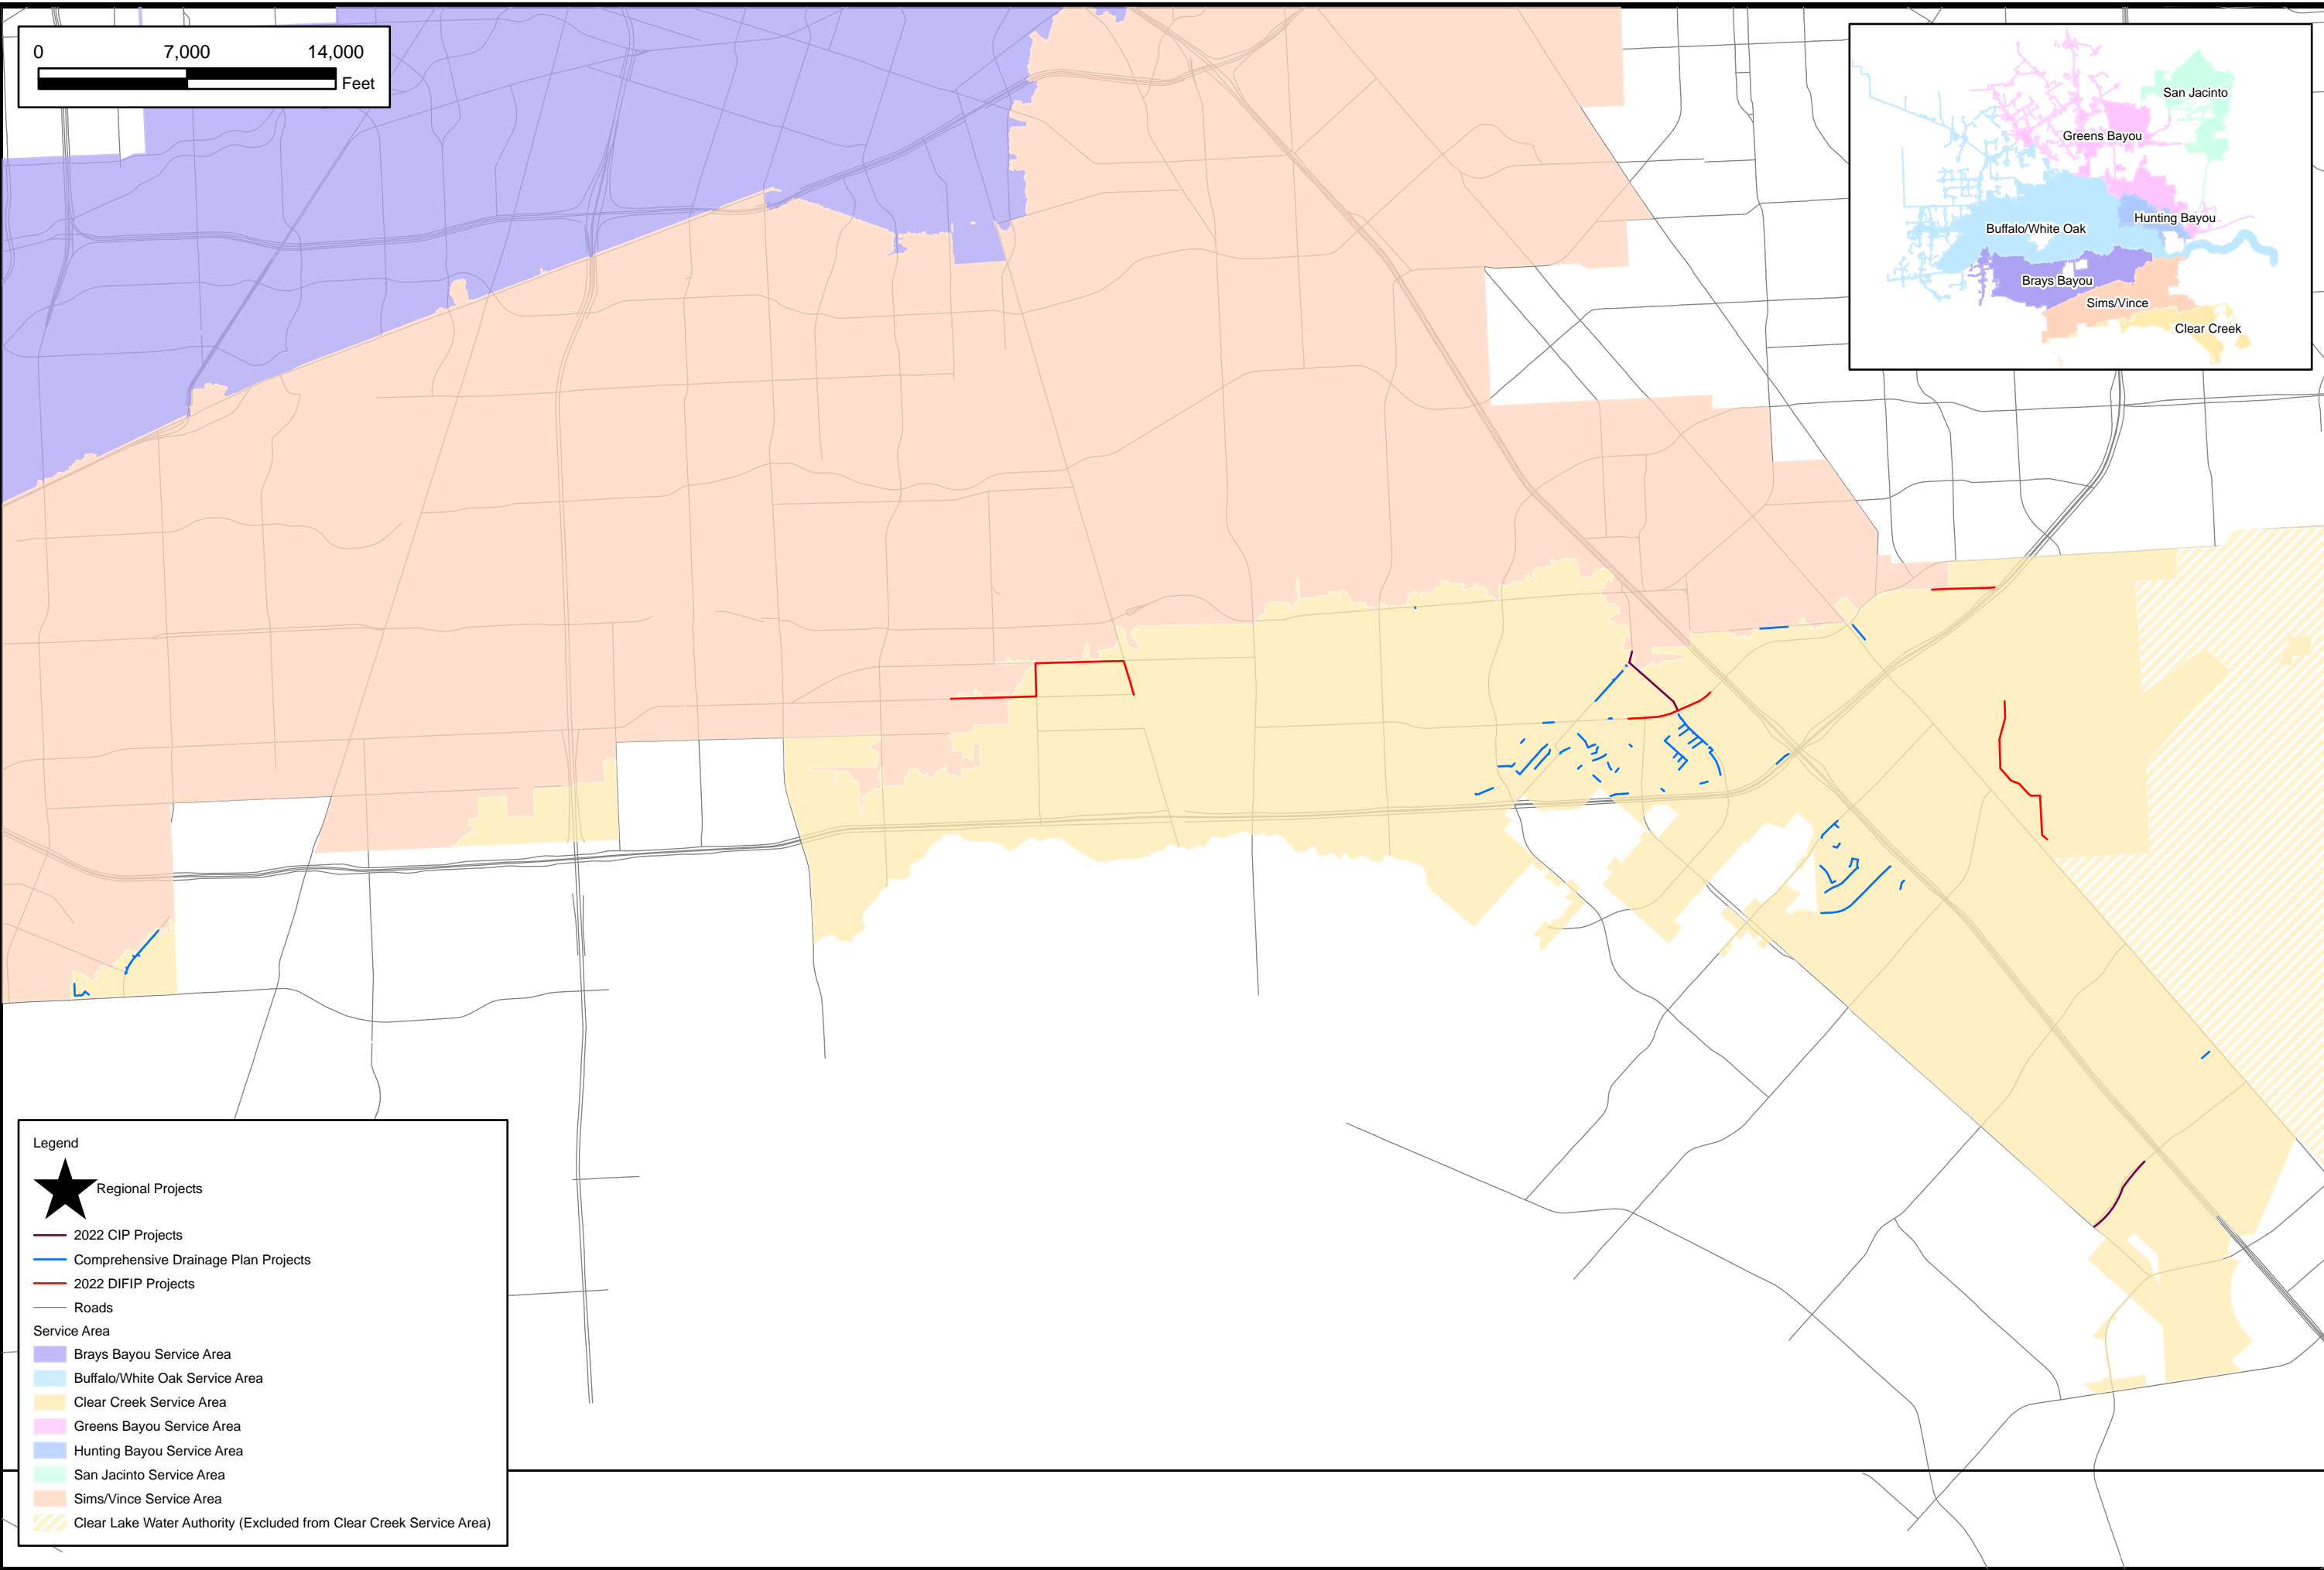


Legend

- Regional Projects
- 2022 CIP Projects
- Comprehensive Drainage Plan Projects
- 2022 DIFIP Projects
- Roads

Service Area

 - Brays Bayou Service Area
- Buffalo/White Oak Service Area
- Clear Creek Service Area
- Greens Bayou Service Area
- Hunting Bayou Service Area
- San Jacinto Service Area
- Sims/Vince Service Area
- Clear Lake Water Authority (Excluded from Clear Creek Service Area)

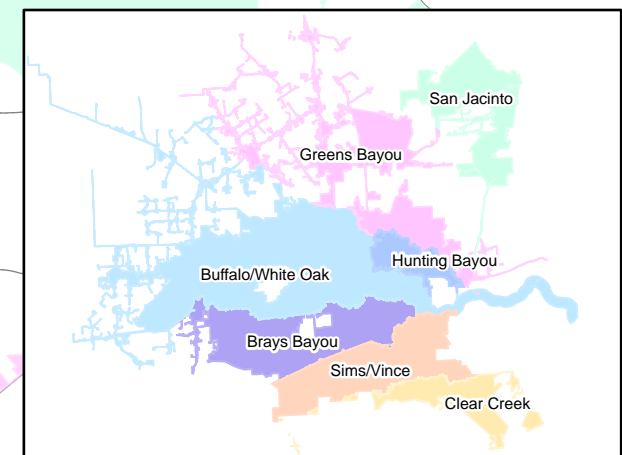

Kimley»Horn
 13455 Noel Road, Suite 700
 Dallas, TX 75240
 (972) 770-3000 Phone
 (972) 239-3820 Fax
 Engineering Firm Registration No. F-928



Houston Drainage Impact Fee
 Improvement Plan:
 Houston, Texas

Drainage Impact Fee
 Improvement Plan:
 Greens Bayou Service Area

DATE:	2023
DESIGN:	KEP
DRAWN:	JWC
CHECKED:	SDG
KHA NO.:	061285302


**SHEET
 A5**











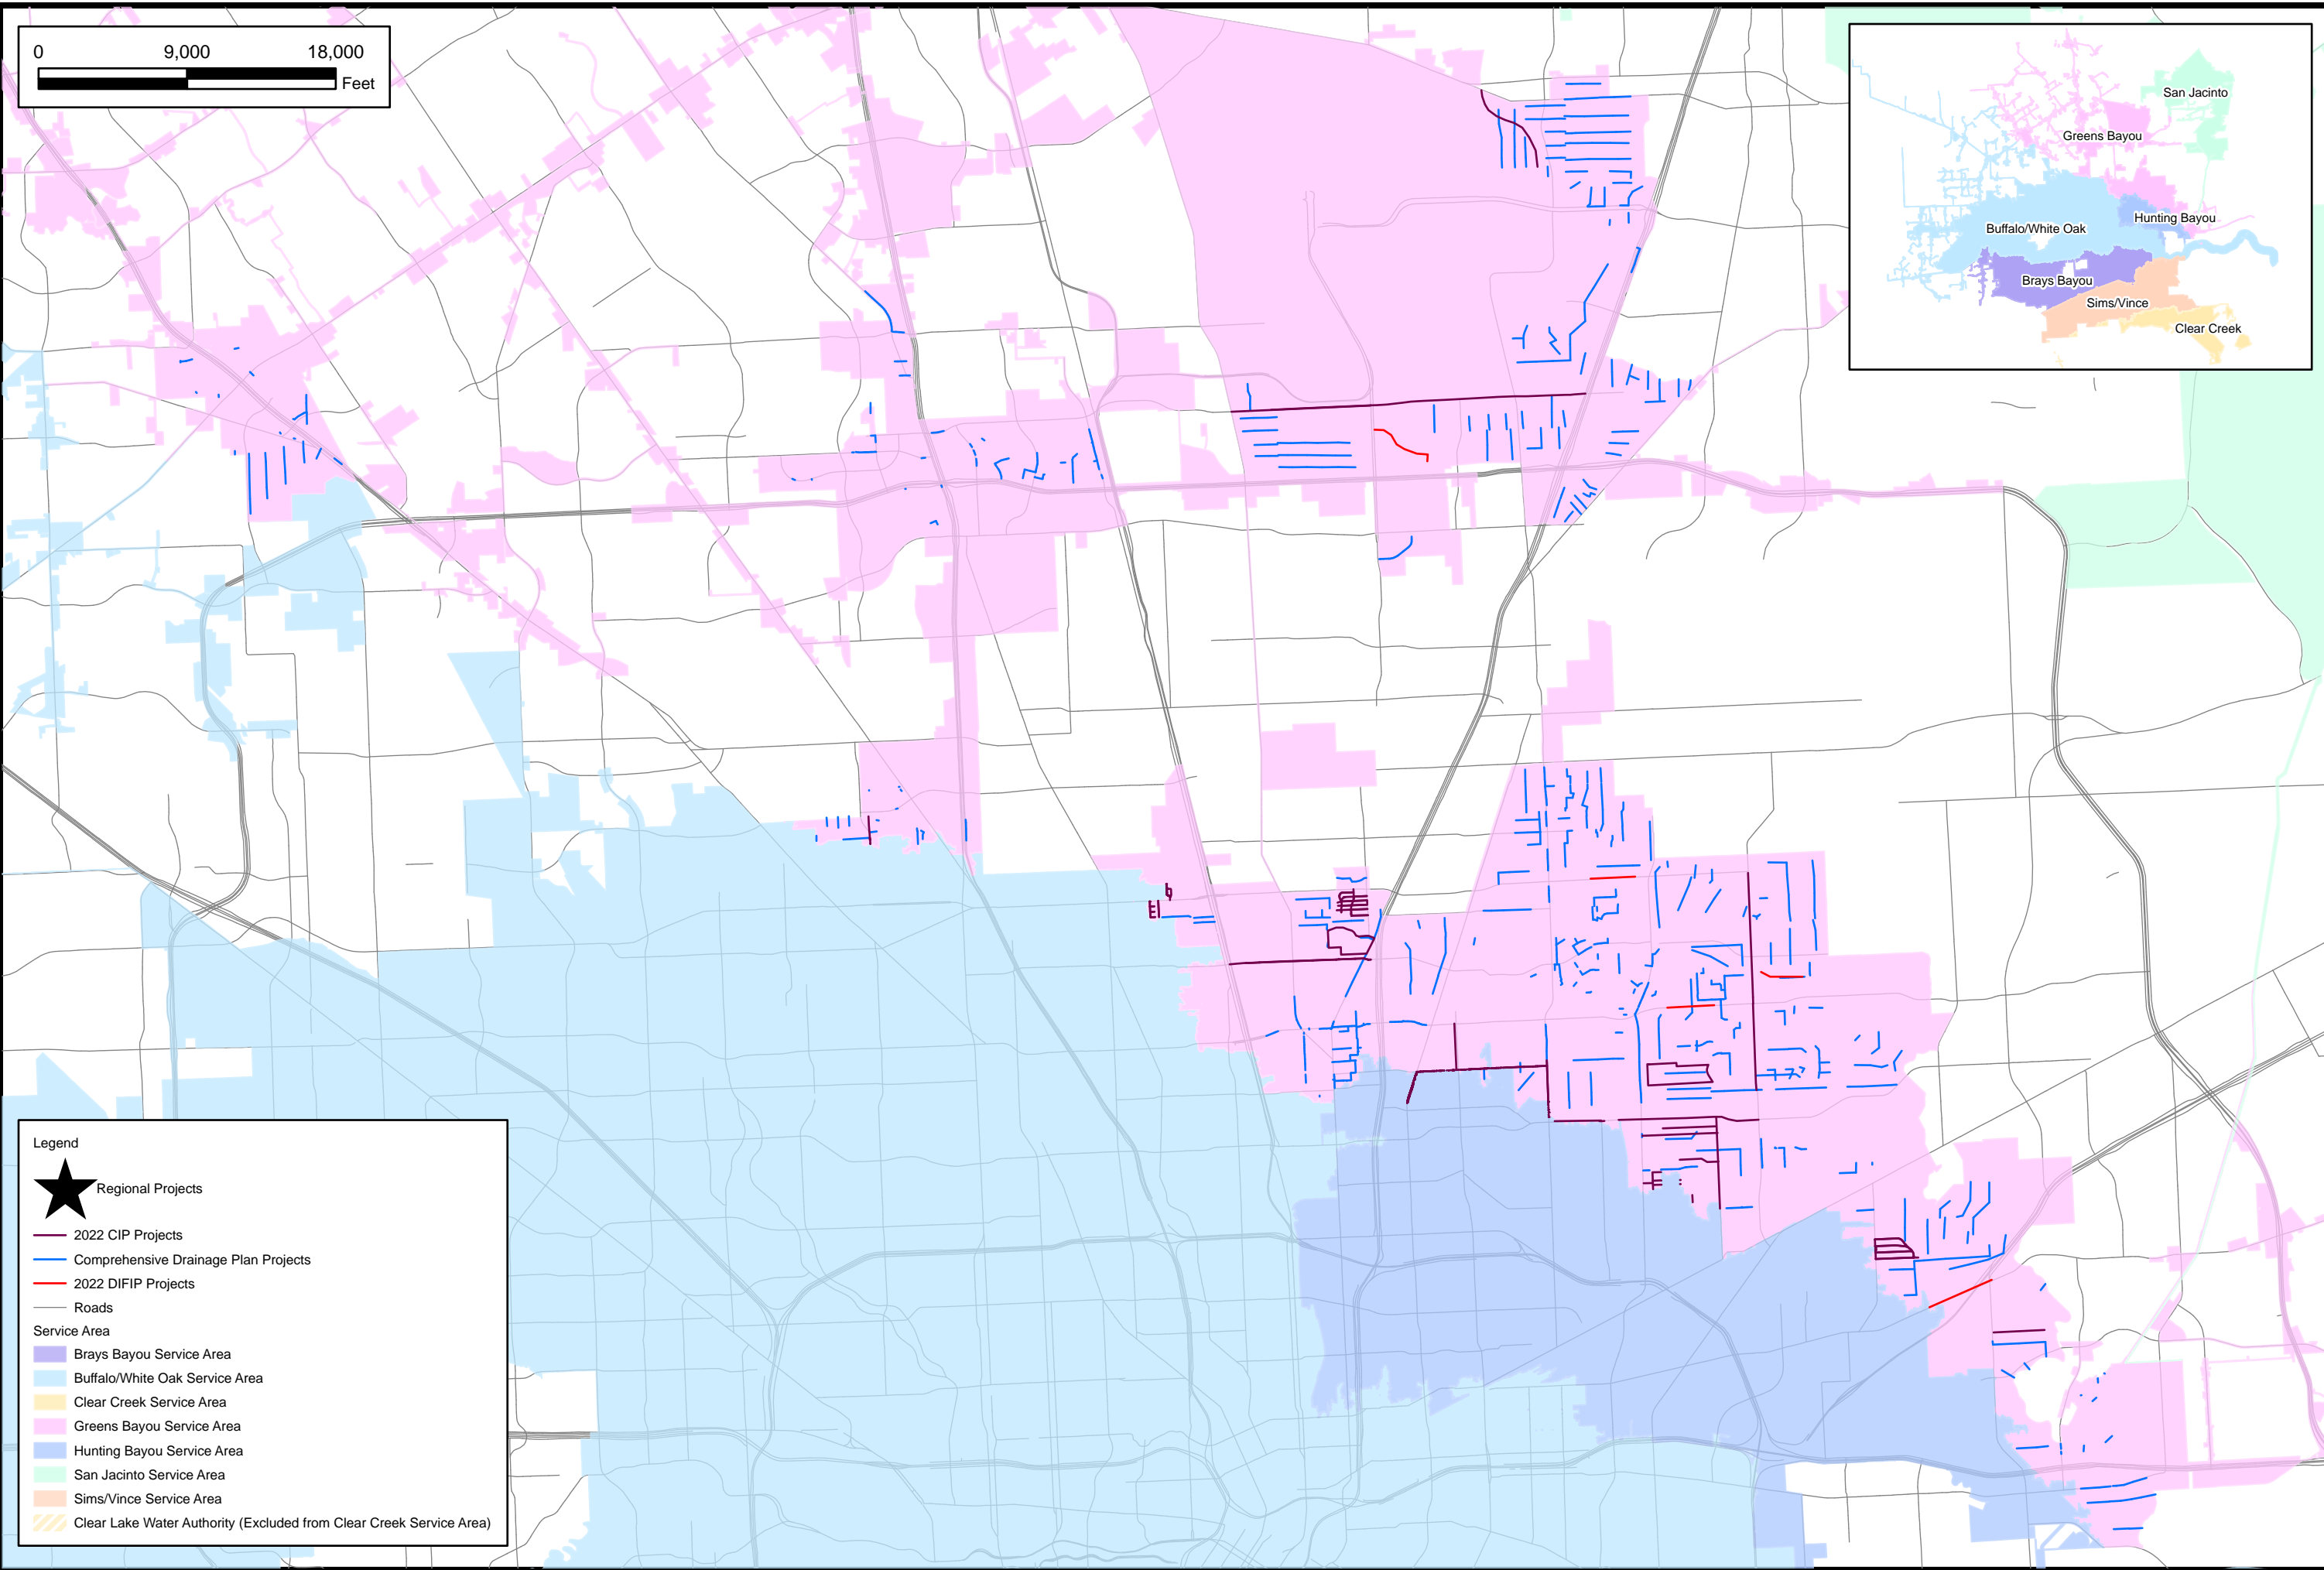


Legend




- Regional Projects
- 2022 CIP Projects
- Comprehensive Drainage Plan Projects
- 2022 DIFIP Projects
- Roads

  Service Area

 
- Brays Bayou Service Area
- Buffalo/White Oak Service Area
- Clear Creek Service Area
- Greens Bayou Service Area
- Hunting Bayou Service Area
- San Jacinto Service Area
- Sims/Vince Service Area
- Clear Lake Water Authority (Excluded from Clear Creek Service Area)



- Legend**
-  Regional Projects
 -  2022 CIP Projects
 -  Comprehensive Drainage Plan Projects
 -  2022 DIFIP Projects
 -  Roads
- Service Area**
-  Brays Bayou Service Area
 -  Buffalo/White Oak Service Area
 -  Clear Creek Service Area
 -  Greens Bayou Service Area
 -  Hunting Bayou Service Area
 -  San Jacinto Service Area
 -  Sims/Vince Service Area
 -  Clear Lake Water Authority (Excluded from Clear Creek Service Area)

 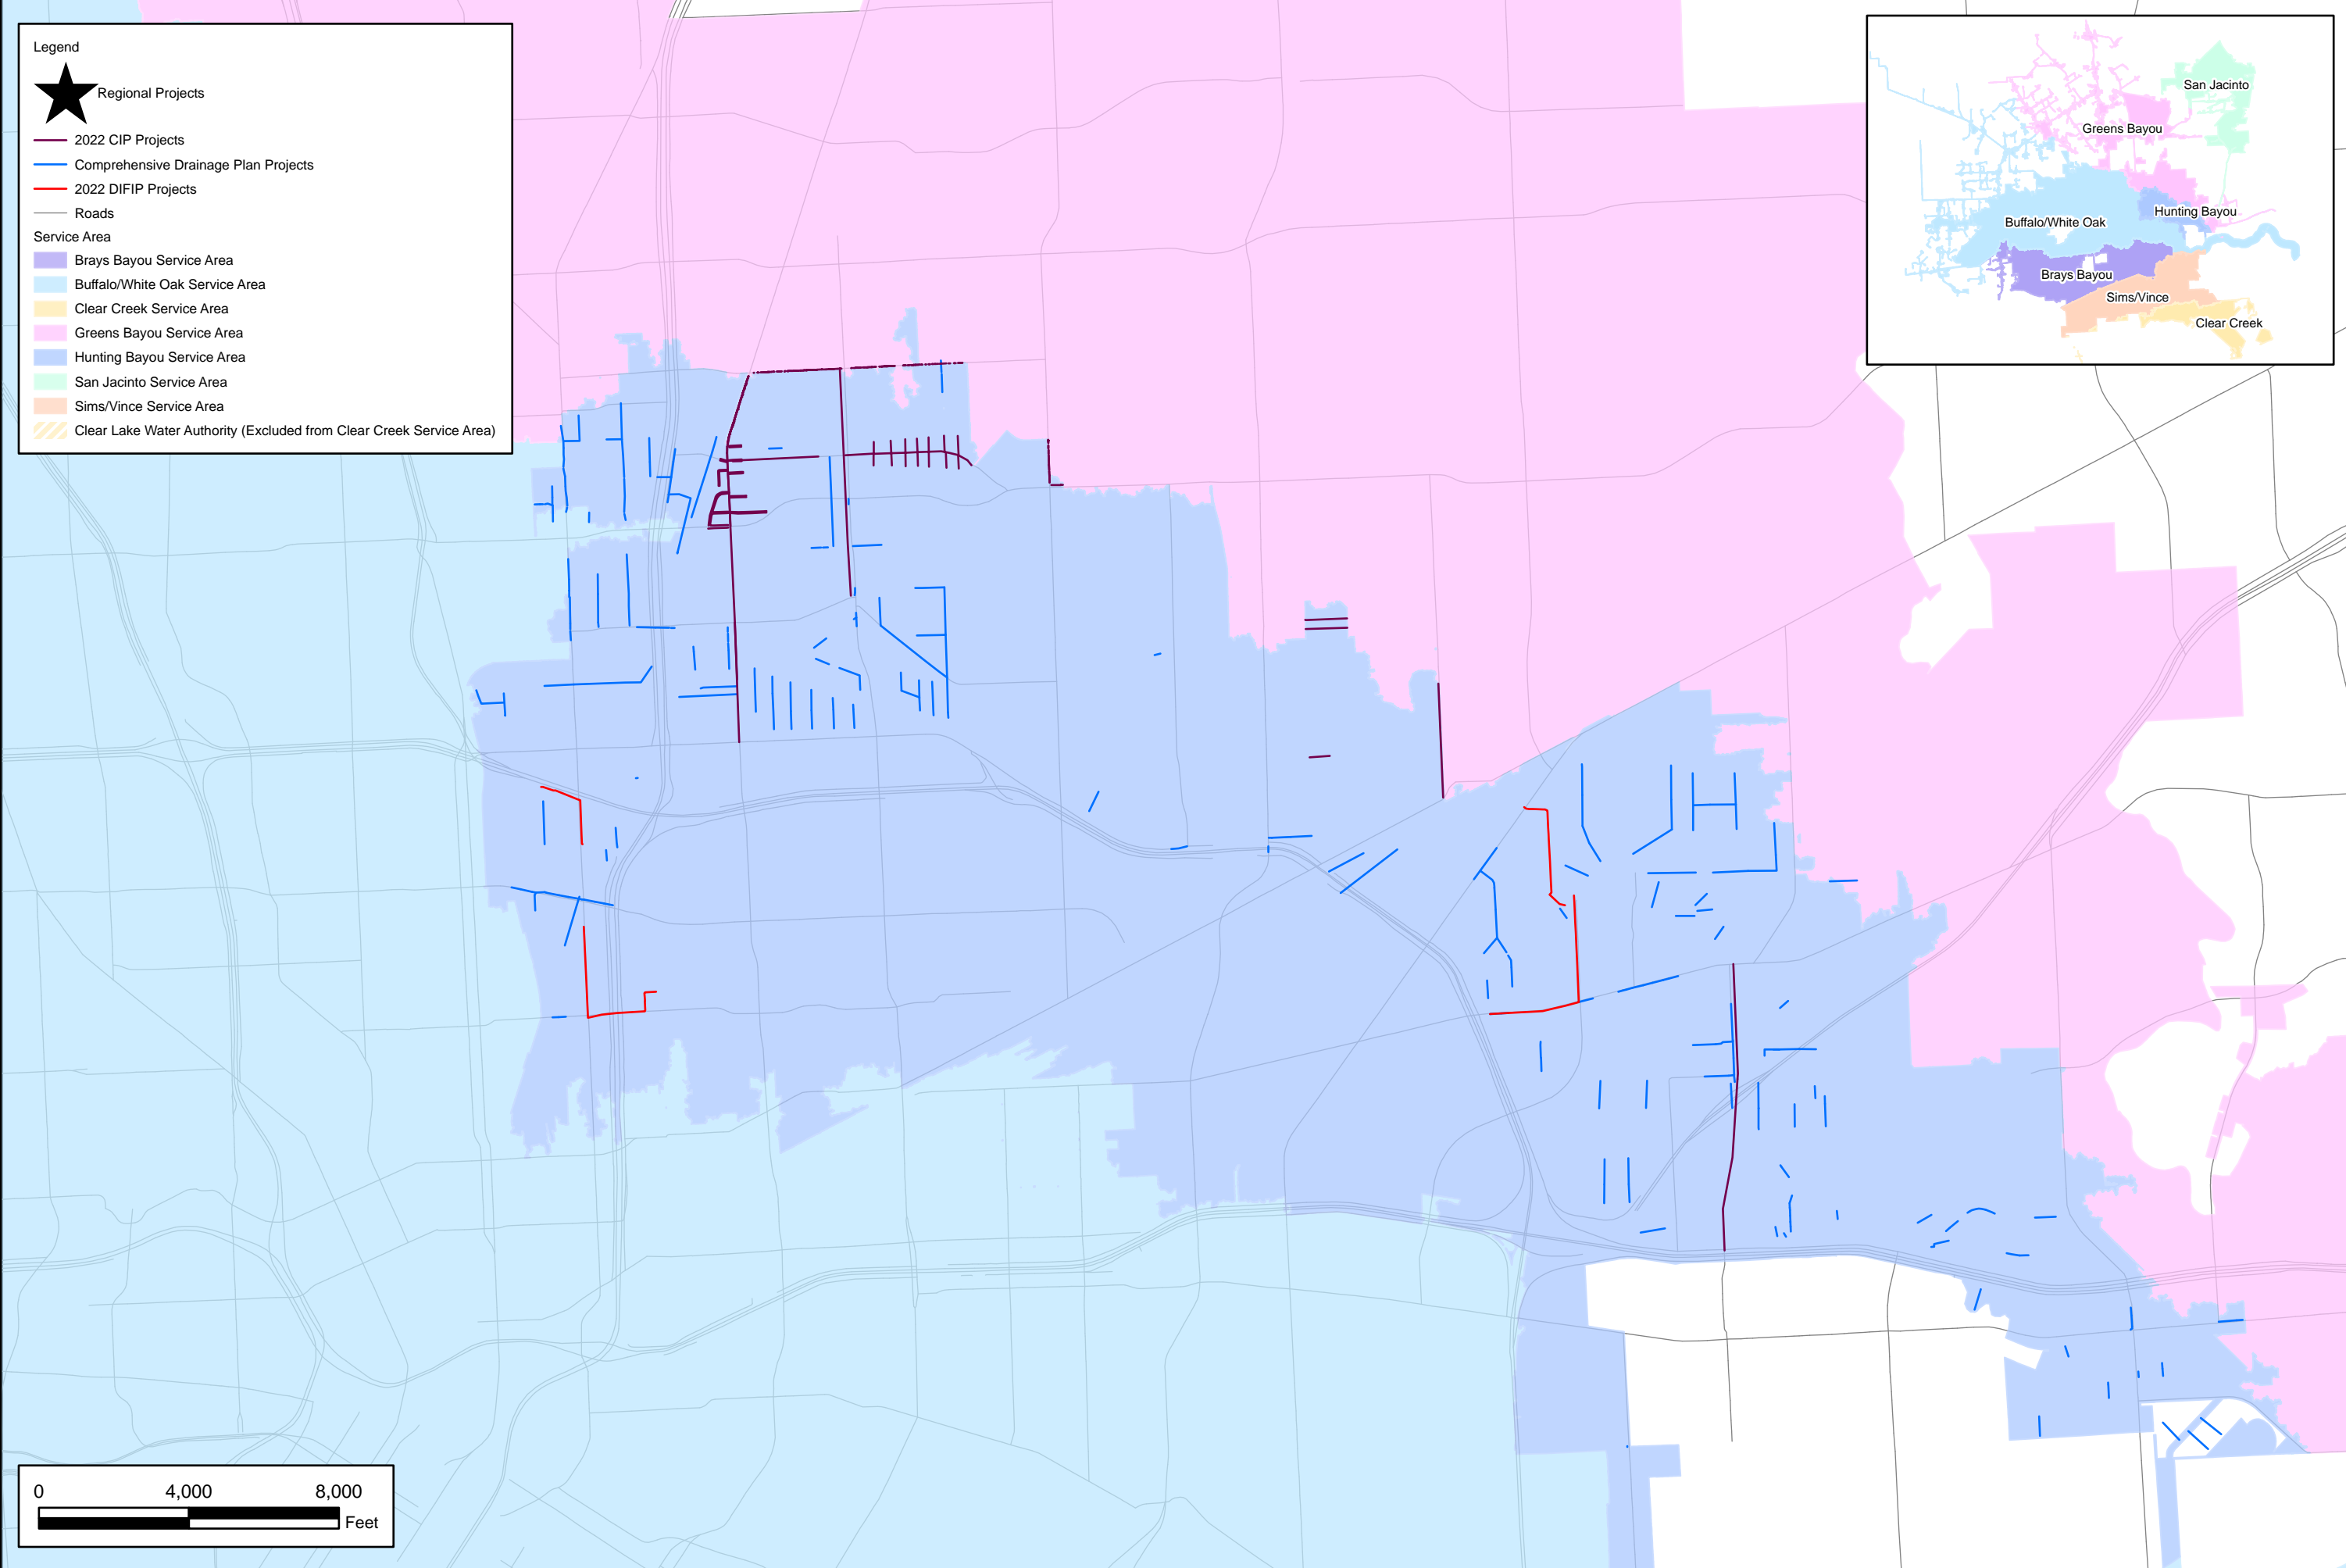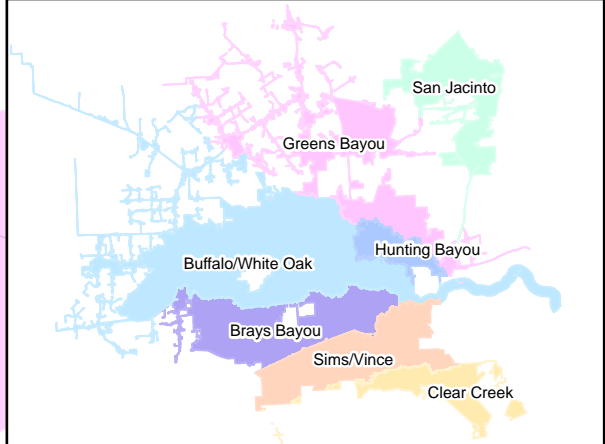

Kimley»Horn
 13455 Noel Road, Suite 700
 Dallas, TX 75240
 (972) 770-3000 Phone
 (972) 239-3820 Fax
 Engineering Firm Registration No. F-928

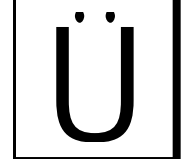

















Houston Drainage Impact Fee
 Houston, Texas

  Drainage Impact Fee
 Improvement Plan:
 Hunting Bayou Service Area


DATE:	2023
DESIGN:	KEP
DRAWN:	JWC
CHECKED:	SDG
KHA NO.:	061285302

 **SHEET
A6**

 - Legend**
-  Regional Projects
 -  2022 CIP Projects
 -  Comprehensive Drainage Plan Projects
 -  2022 DIFIP Projects
 -  Roads
- Service Area**
-  Brays Bayou Service Area
 -  Buffalo/White Oak Service Area
 -  Clear Creek Service Area
 -  Greens Bayou Service Area
 -  Hunting Bayou Service Area
 -  San Jacinto Service Area
 -  Sims/Vince Service Area
 -  Clear Lake Water Authority (Excluded from Clear Creek Service Area)

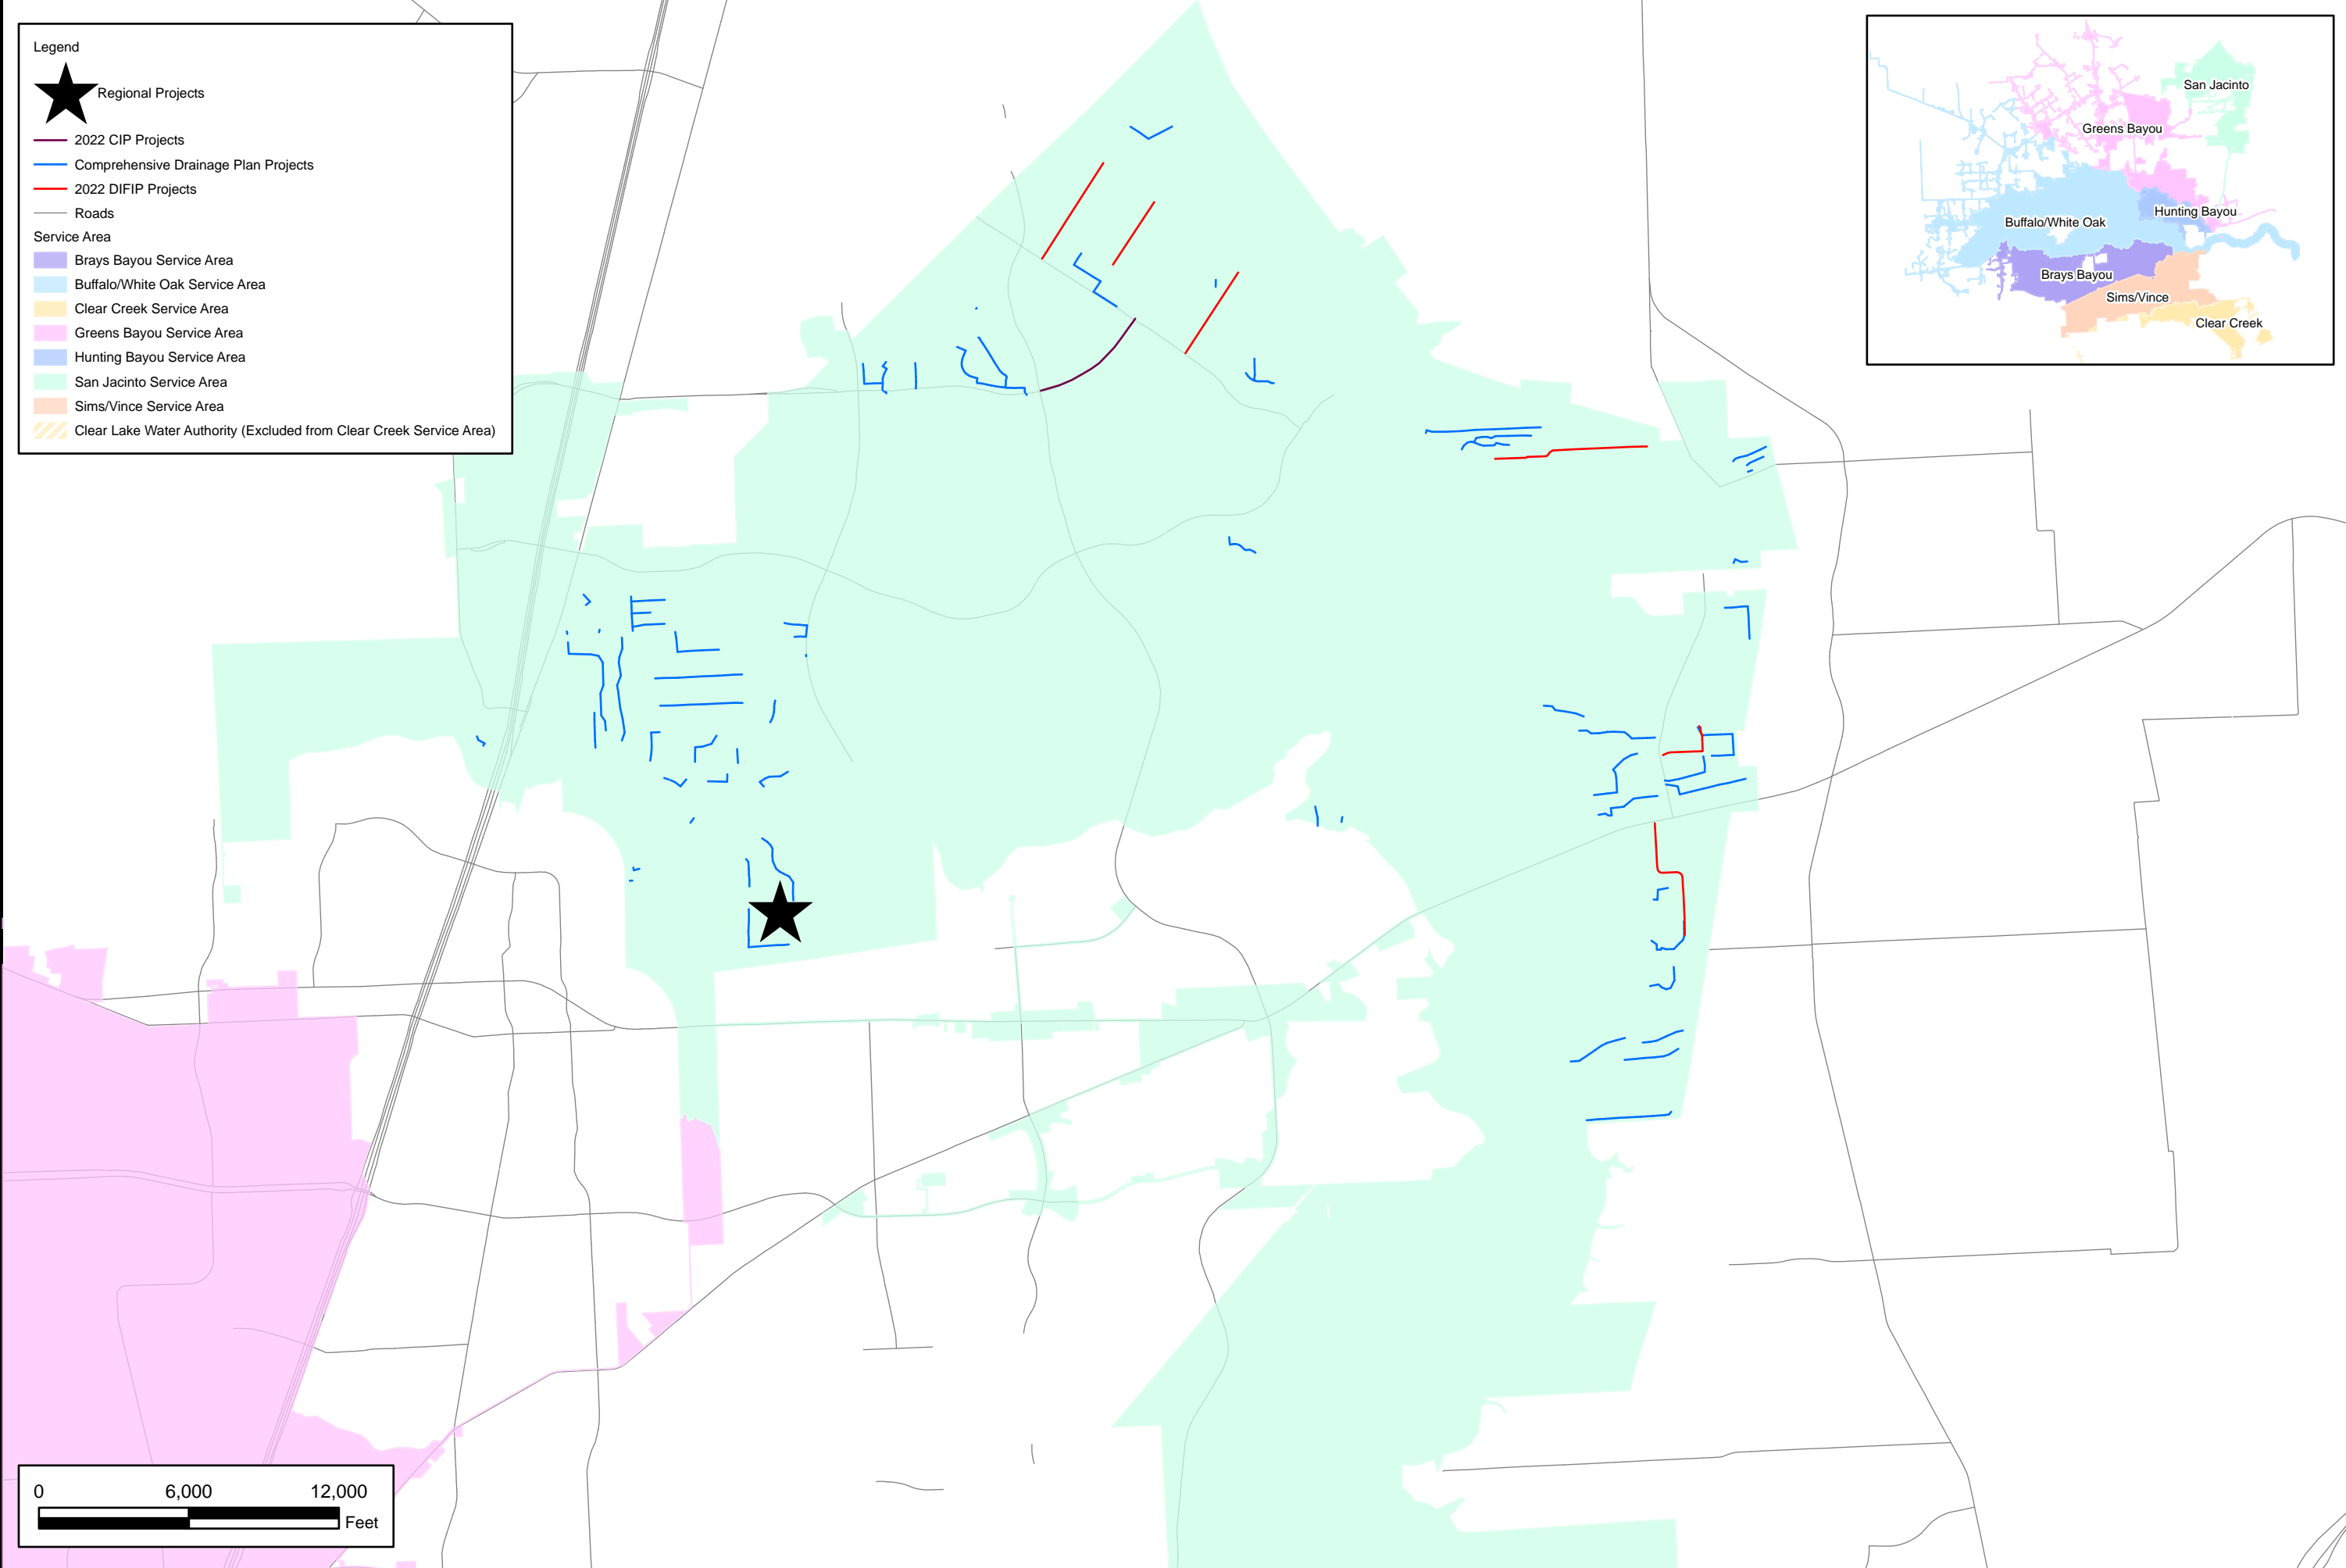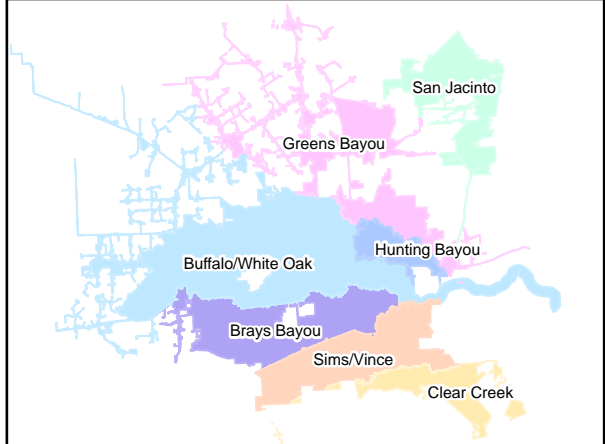

Kimley»Horn
 13455 Noel Road, Suite 700
 Dallas, TX 75240
 (972) 770-3000 Phone
 (972) 239-3820 Fax
 Engineering Firm Registration No. F-928

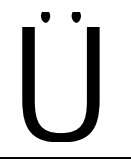






Houston Drainage Impact Fee
 Houston, Texas

Drainage Impact Fee
 Improvement Plan:
 San Jacinto Service Area


 
 





DATE:	2023
DESIGN:	KEP
DRAWN:	JWC
CHECKED:	SDG
KHA NO.:	061285302




**SHEET
 A7**

Legend

 -  Regional Projects
-  2022 CIP Projects
-  Comprehensive Drainage Plan Projects
-  2022 DIFIP Projects
-  Roads

Service Area

 -  Brays Bayou Service Area
-  Buffalo/White Oak Service Area
-  Clear Creek Service Area
-  Greens Bayou Service Area
-  Hunting Bayou Service Area
-  San Jacinto Service Area
-  Sims/Vince Service Area
-  Clear Lake Water Authority (Excluded from Clear Creek Service Area)

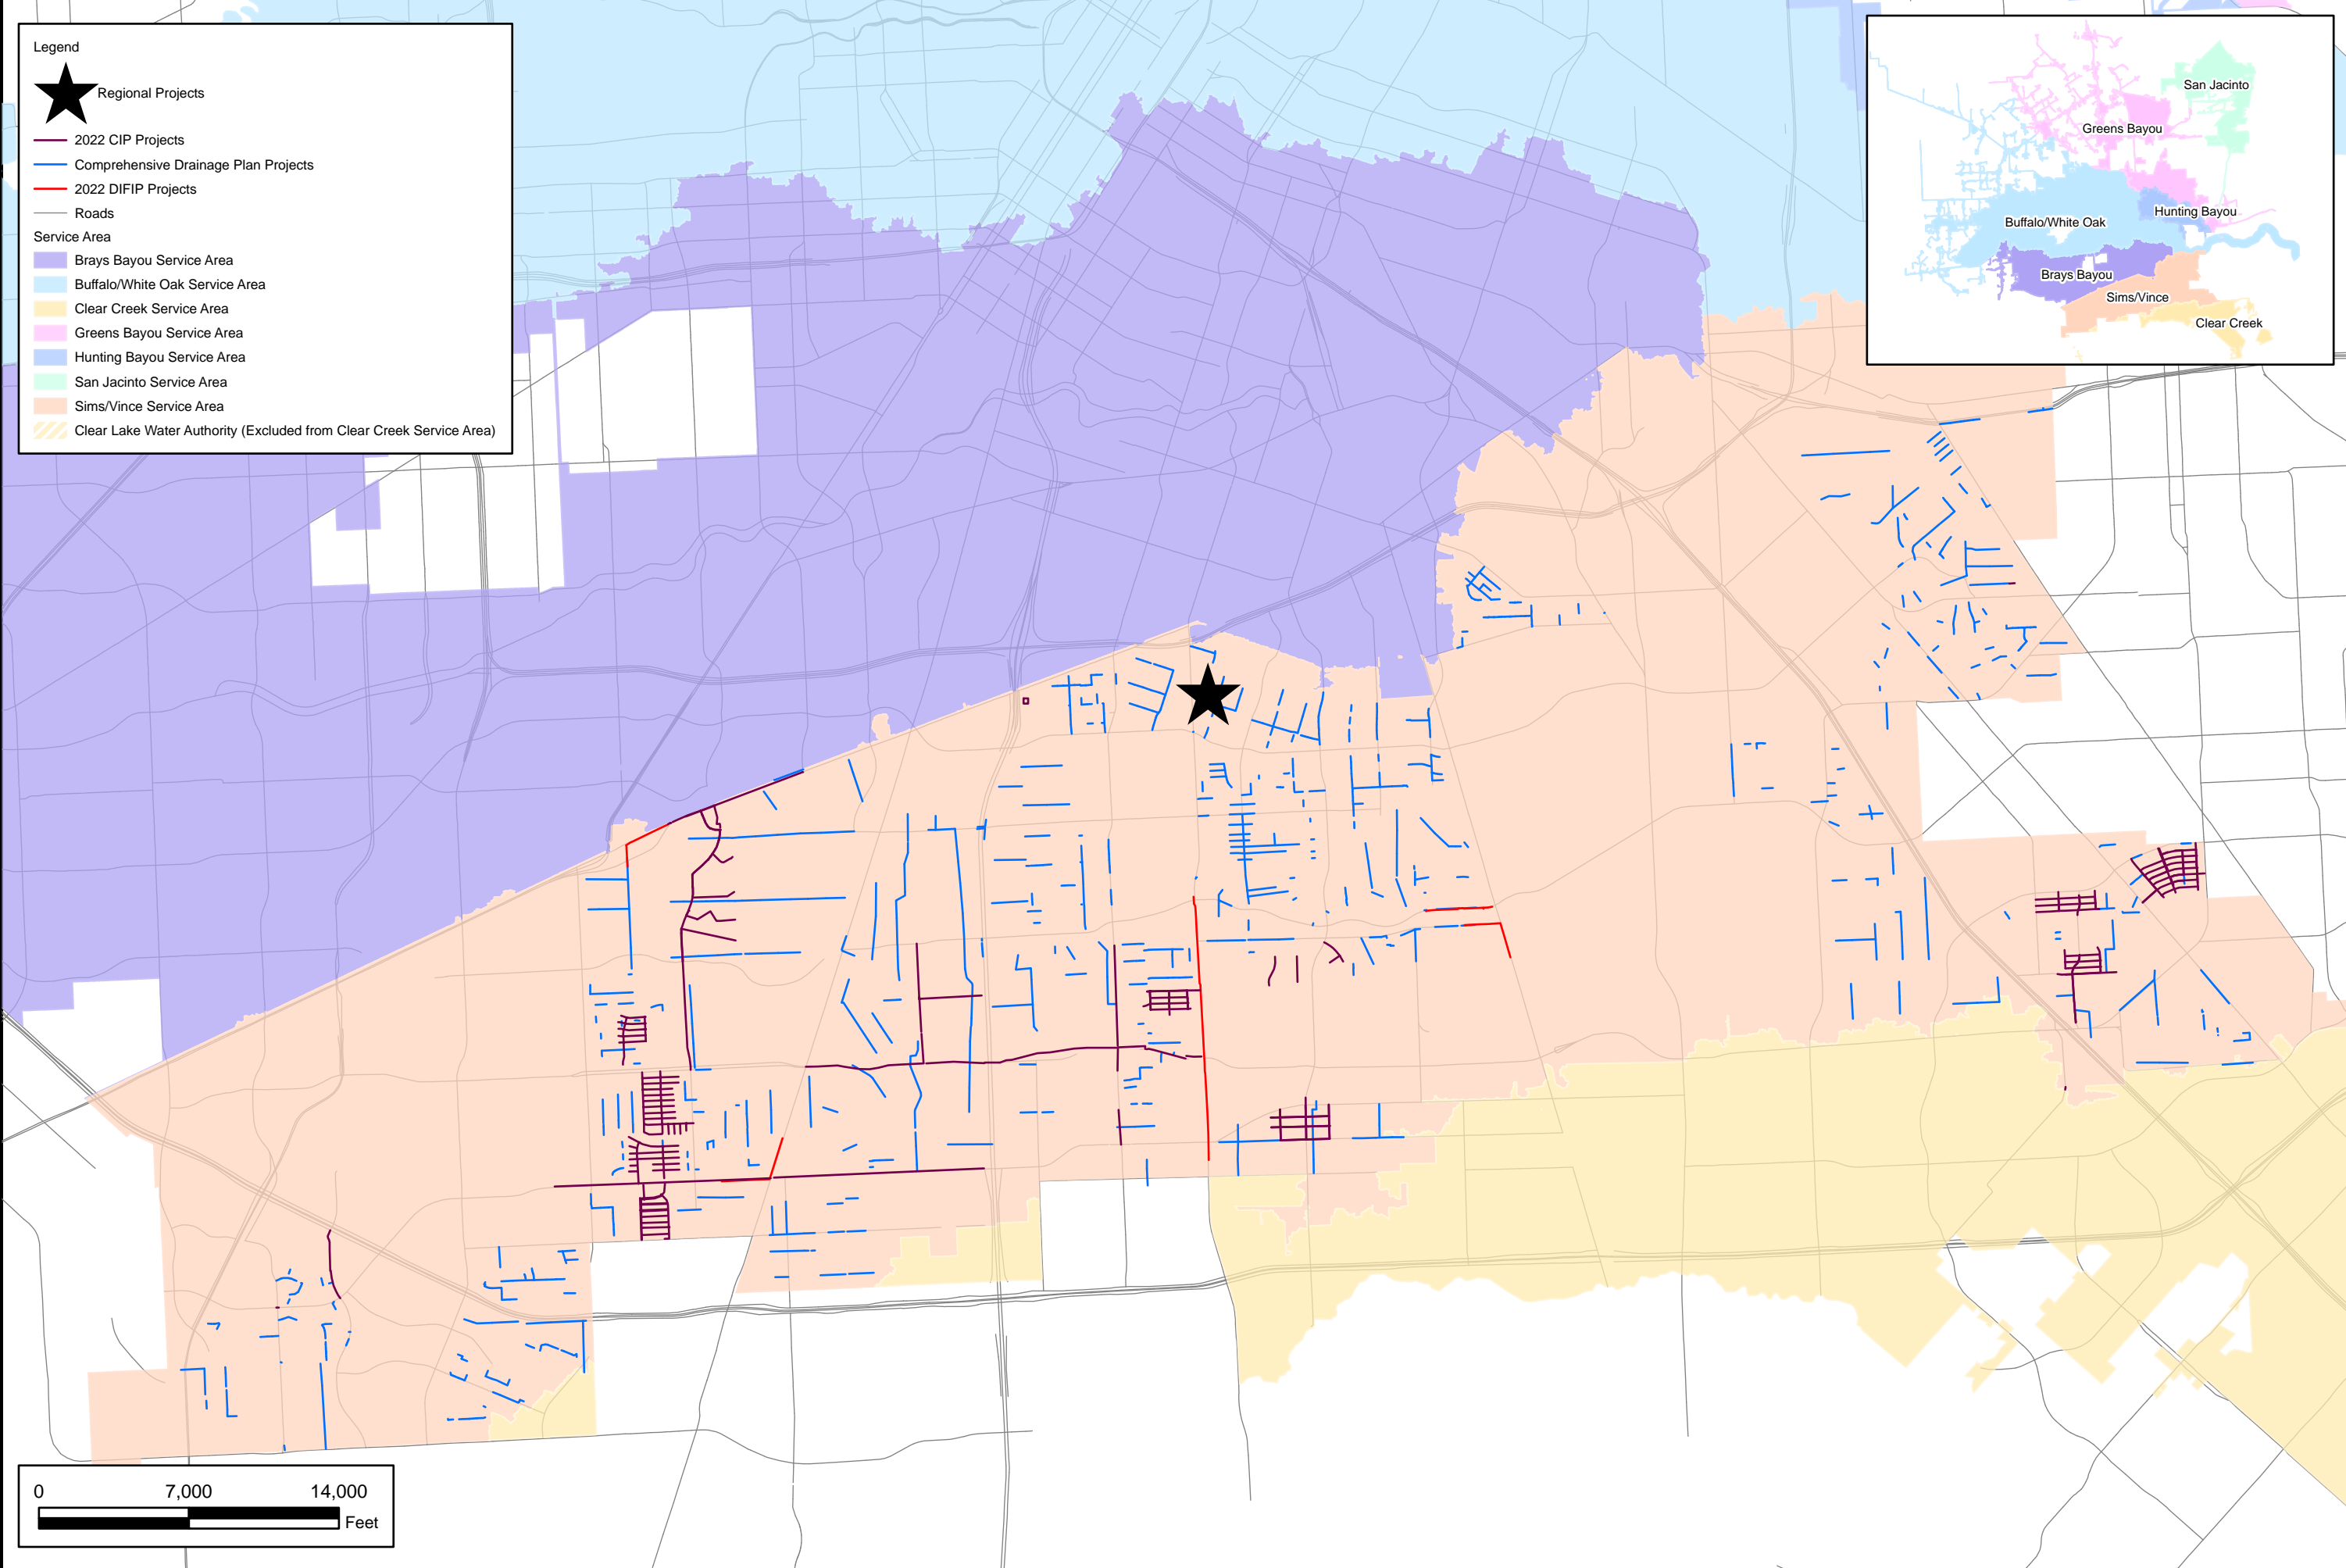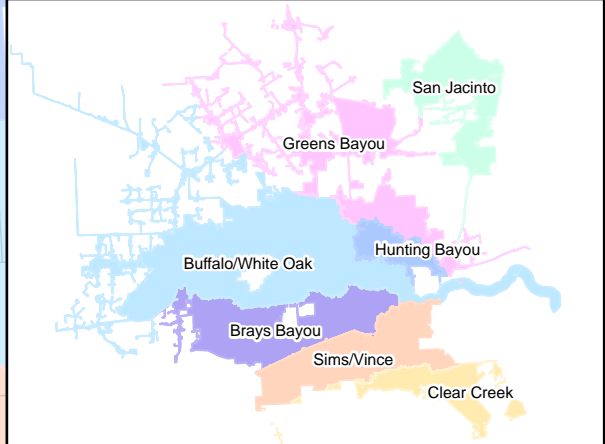

Kimley»Horn
 13455 Noel Road, Suite 700
 Dallas, TX 75240
 (972) 770-3000 Phone
 (972) 239-3820 Fax
 Engineering Firm Registration No. F-928



Houston Drainage Impact Fee
 Houston, Texas

Drainage Impact Fee
 Improvement Plan:
 Sims/Vince Service Area

DATE:	2023
DESIGN:	KEP
DRAWN:	JWC
CHECKED:	SDG
KHA NO.:	061285302

**SHEET
A8**